



DATE: _____ BY: _____
 PLAN
 SUBMITTED: _____
 NOTE BOOK: _____
 ALIGNMENT CHECKED: _____
 RT-OF-WAY CHECKED: _____
 NO. _____

DATE: _____ BY: _____
 PROFILE
 SUBMITTED: _____
 GRADES CHECKED: _____
 BY: M. M. NOSTED
 STRUCTURE NOTATION CHECKED: _____
 NO. _____

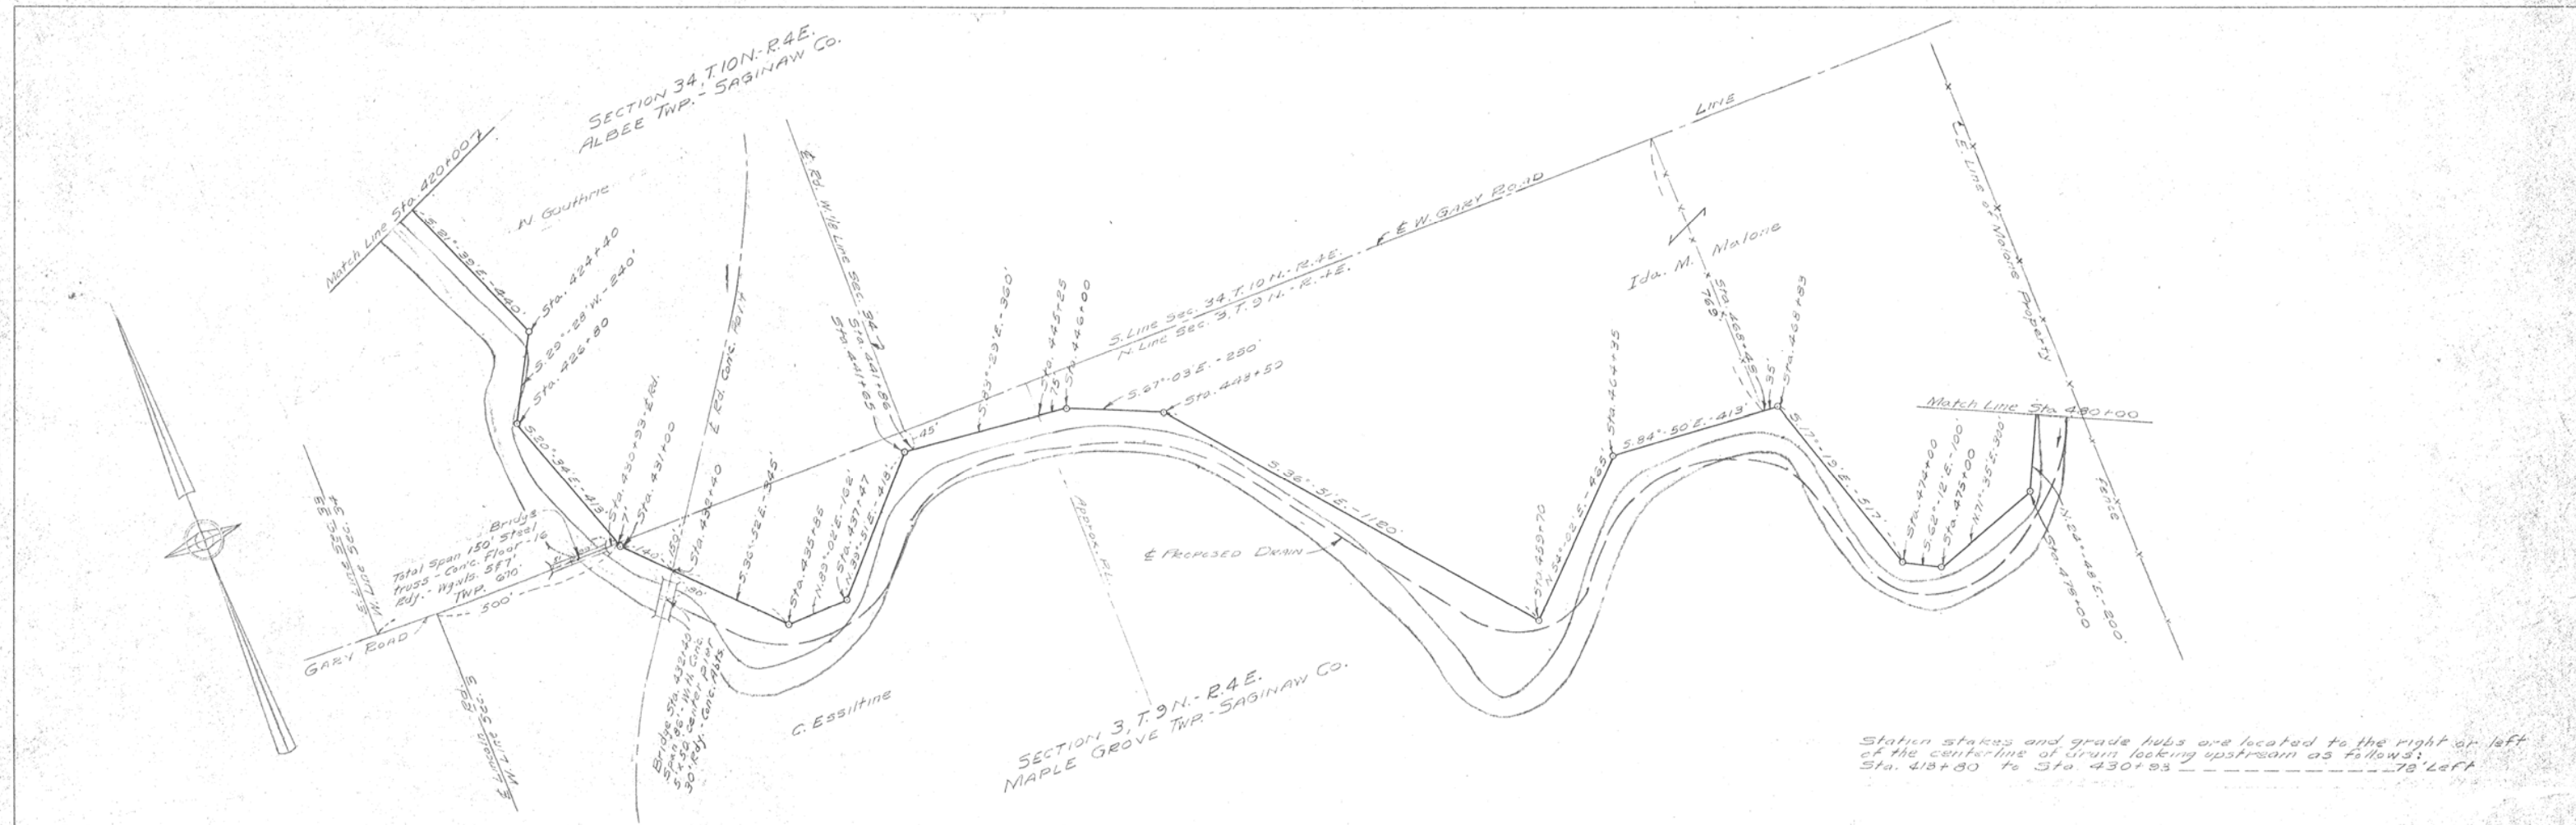

Station stakes and grade hubs are located to the right or left of the centerline of drain looking upstream as follows:
 Sta. 418+80 to Sta. 430+93 - 78' Left

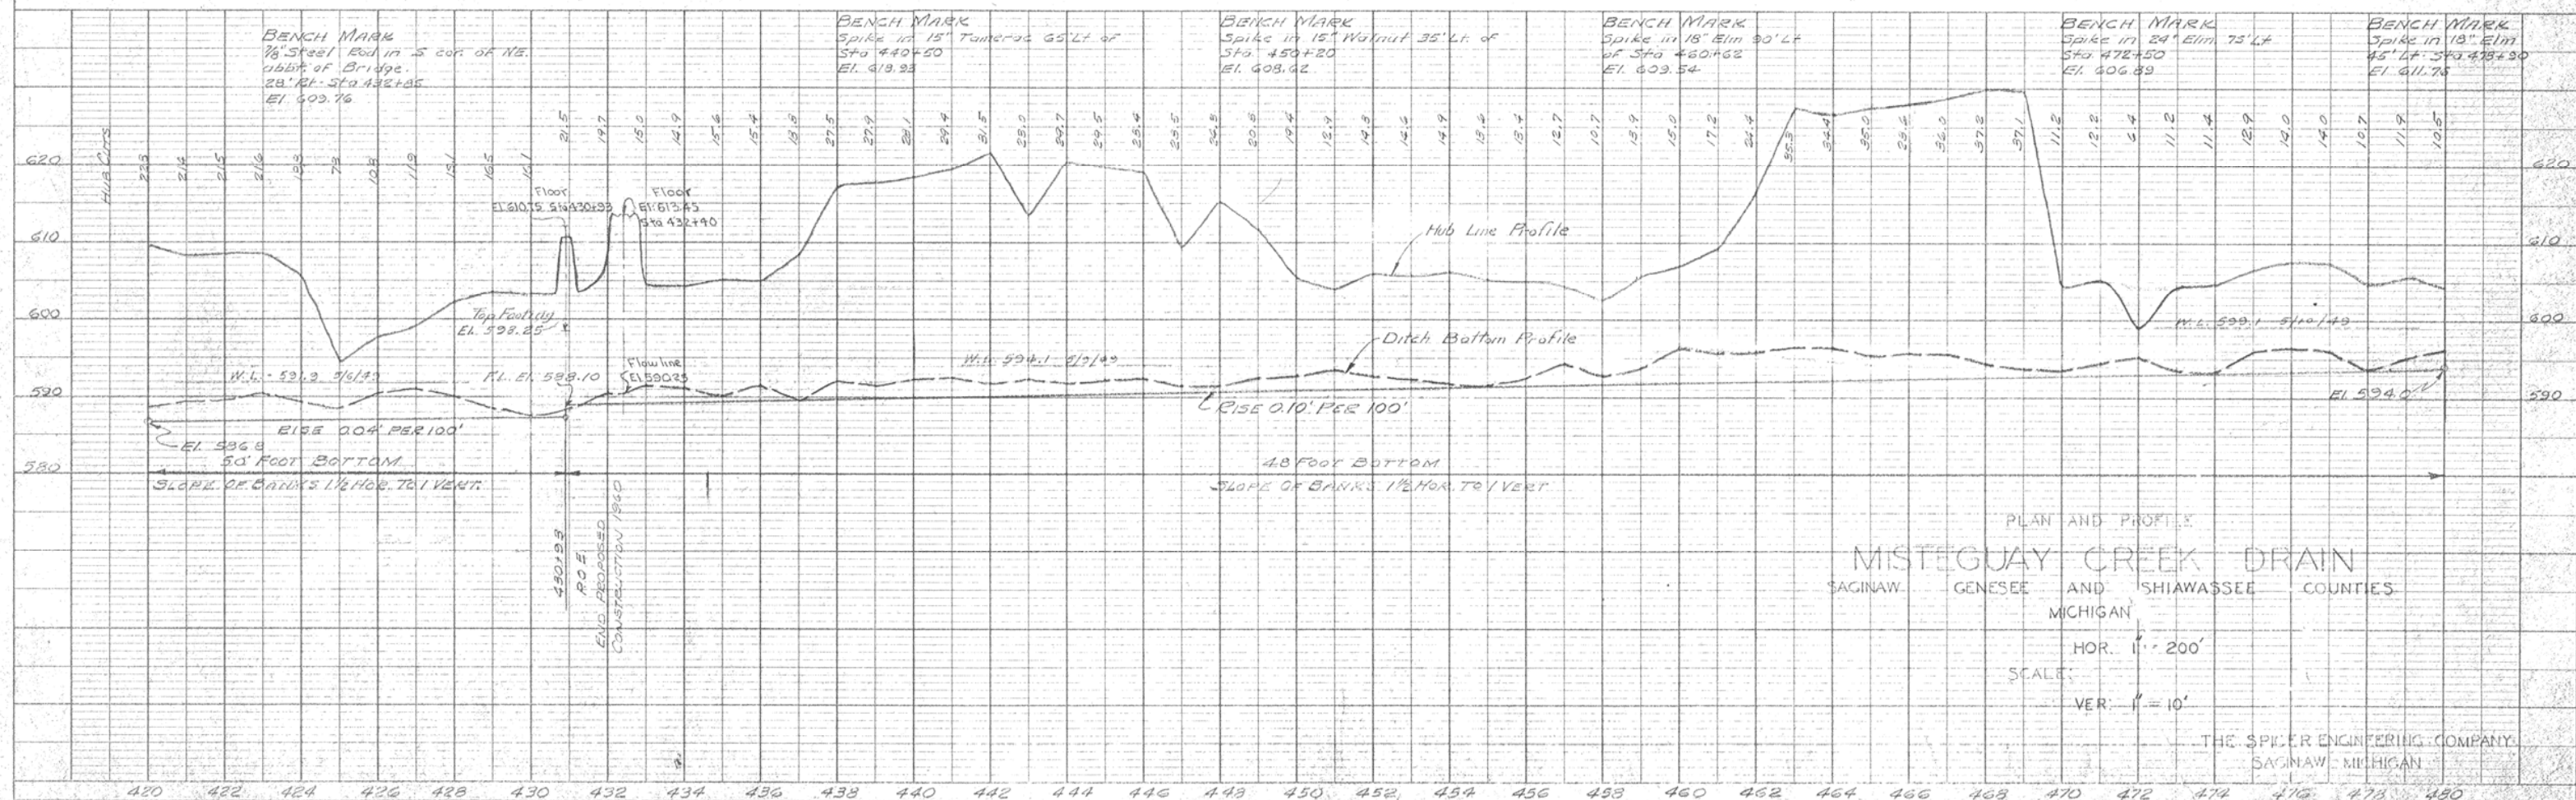

PLAN AND PROFILE
 MISTEGUAY CREEK DRAIN
 SAGINAW, GENESEE AND SHIawassee COUNTIES
 MICHIGAN
 HOR. 1" = 200'
 SCALE:
 VER. 1" = 10'

THE SPIKER ENGINEERING COMPANY
 SAGINAW, MICHIGAN